




VENT OUTLET COVERED WITH TWO LAYERS OF NON CORRODING METAL WIRE GAUGE OF 11 MESH TO THE LINEAR CENTIMETER

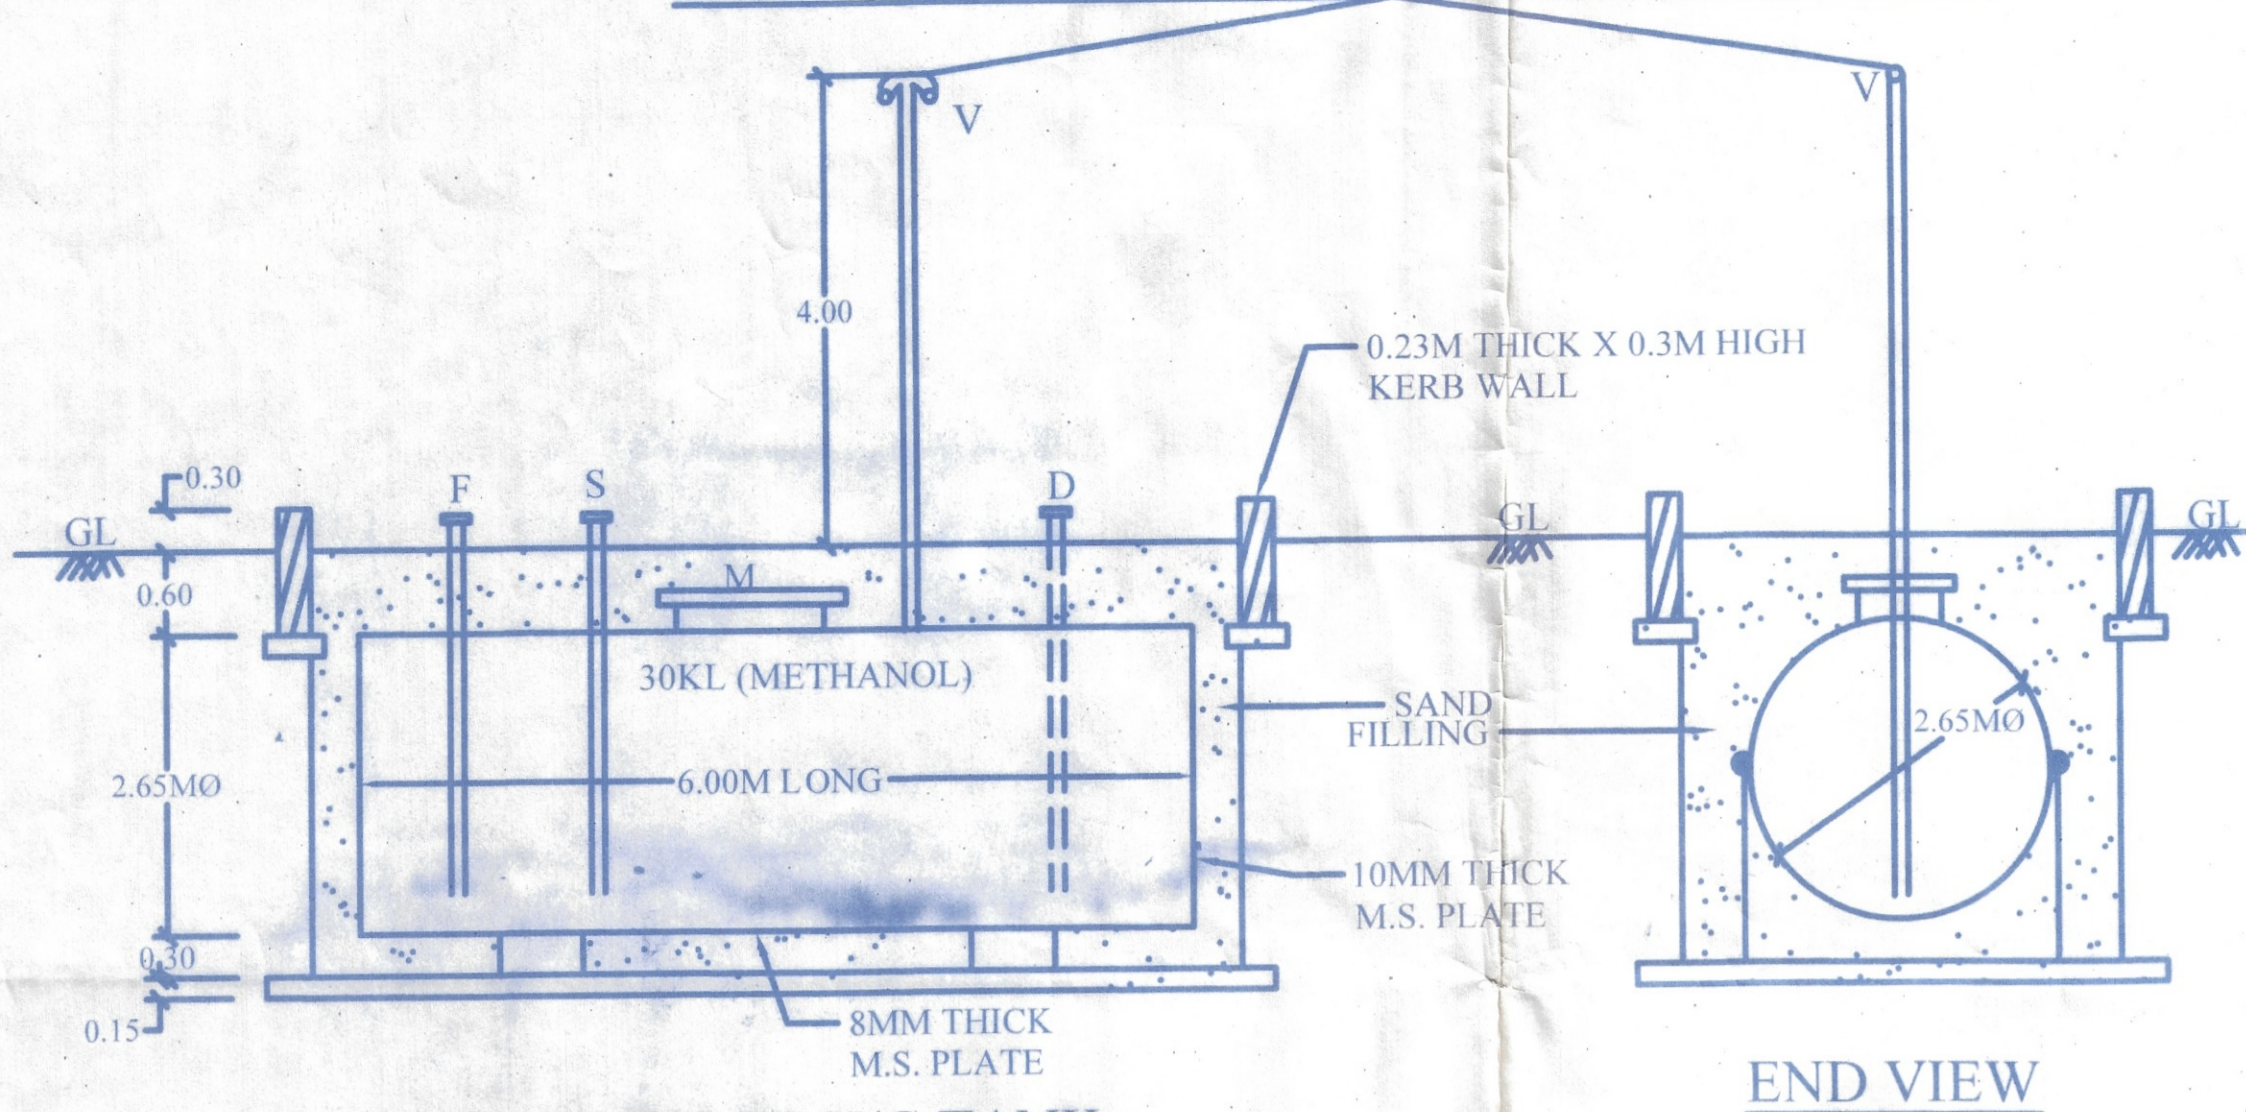


ELEVATION OF U/G TANK

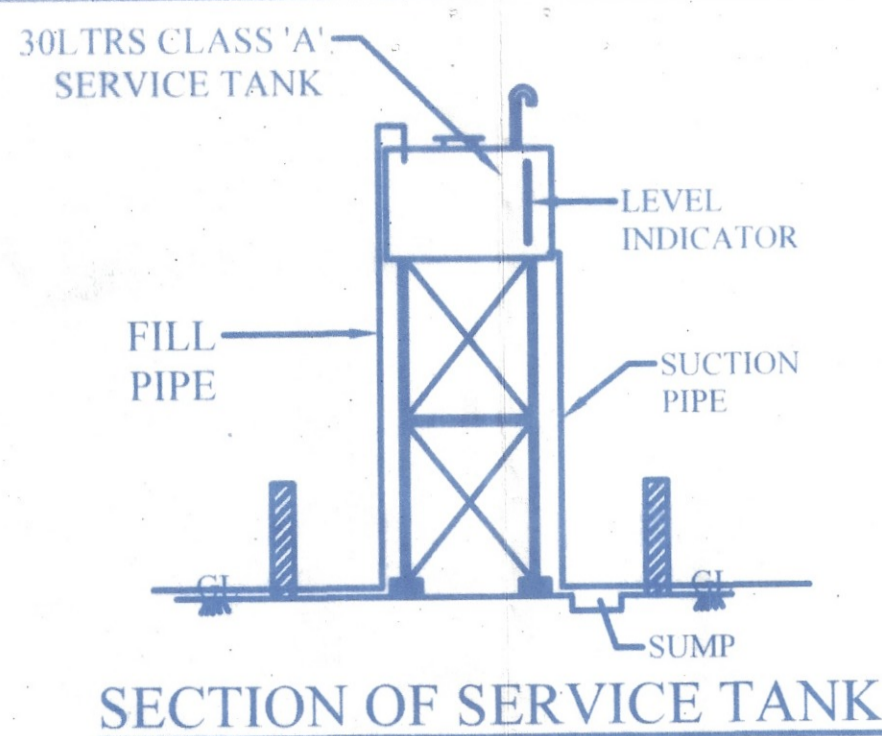

SECTION OF SERVICE TANK

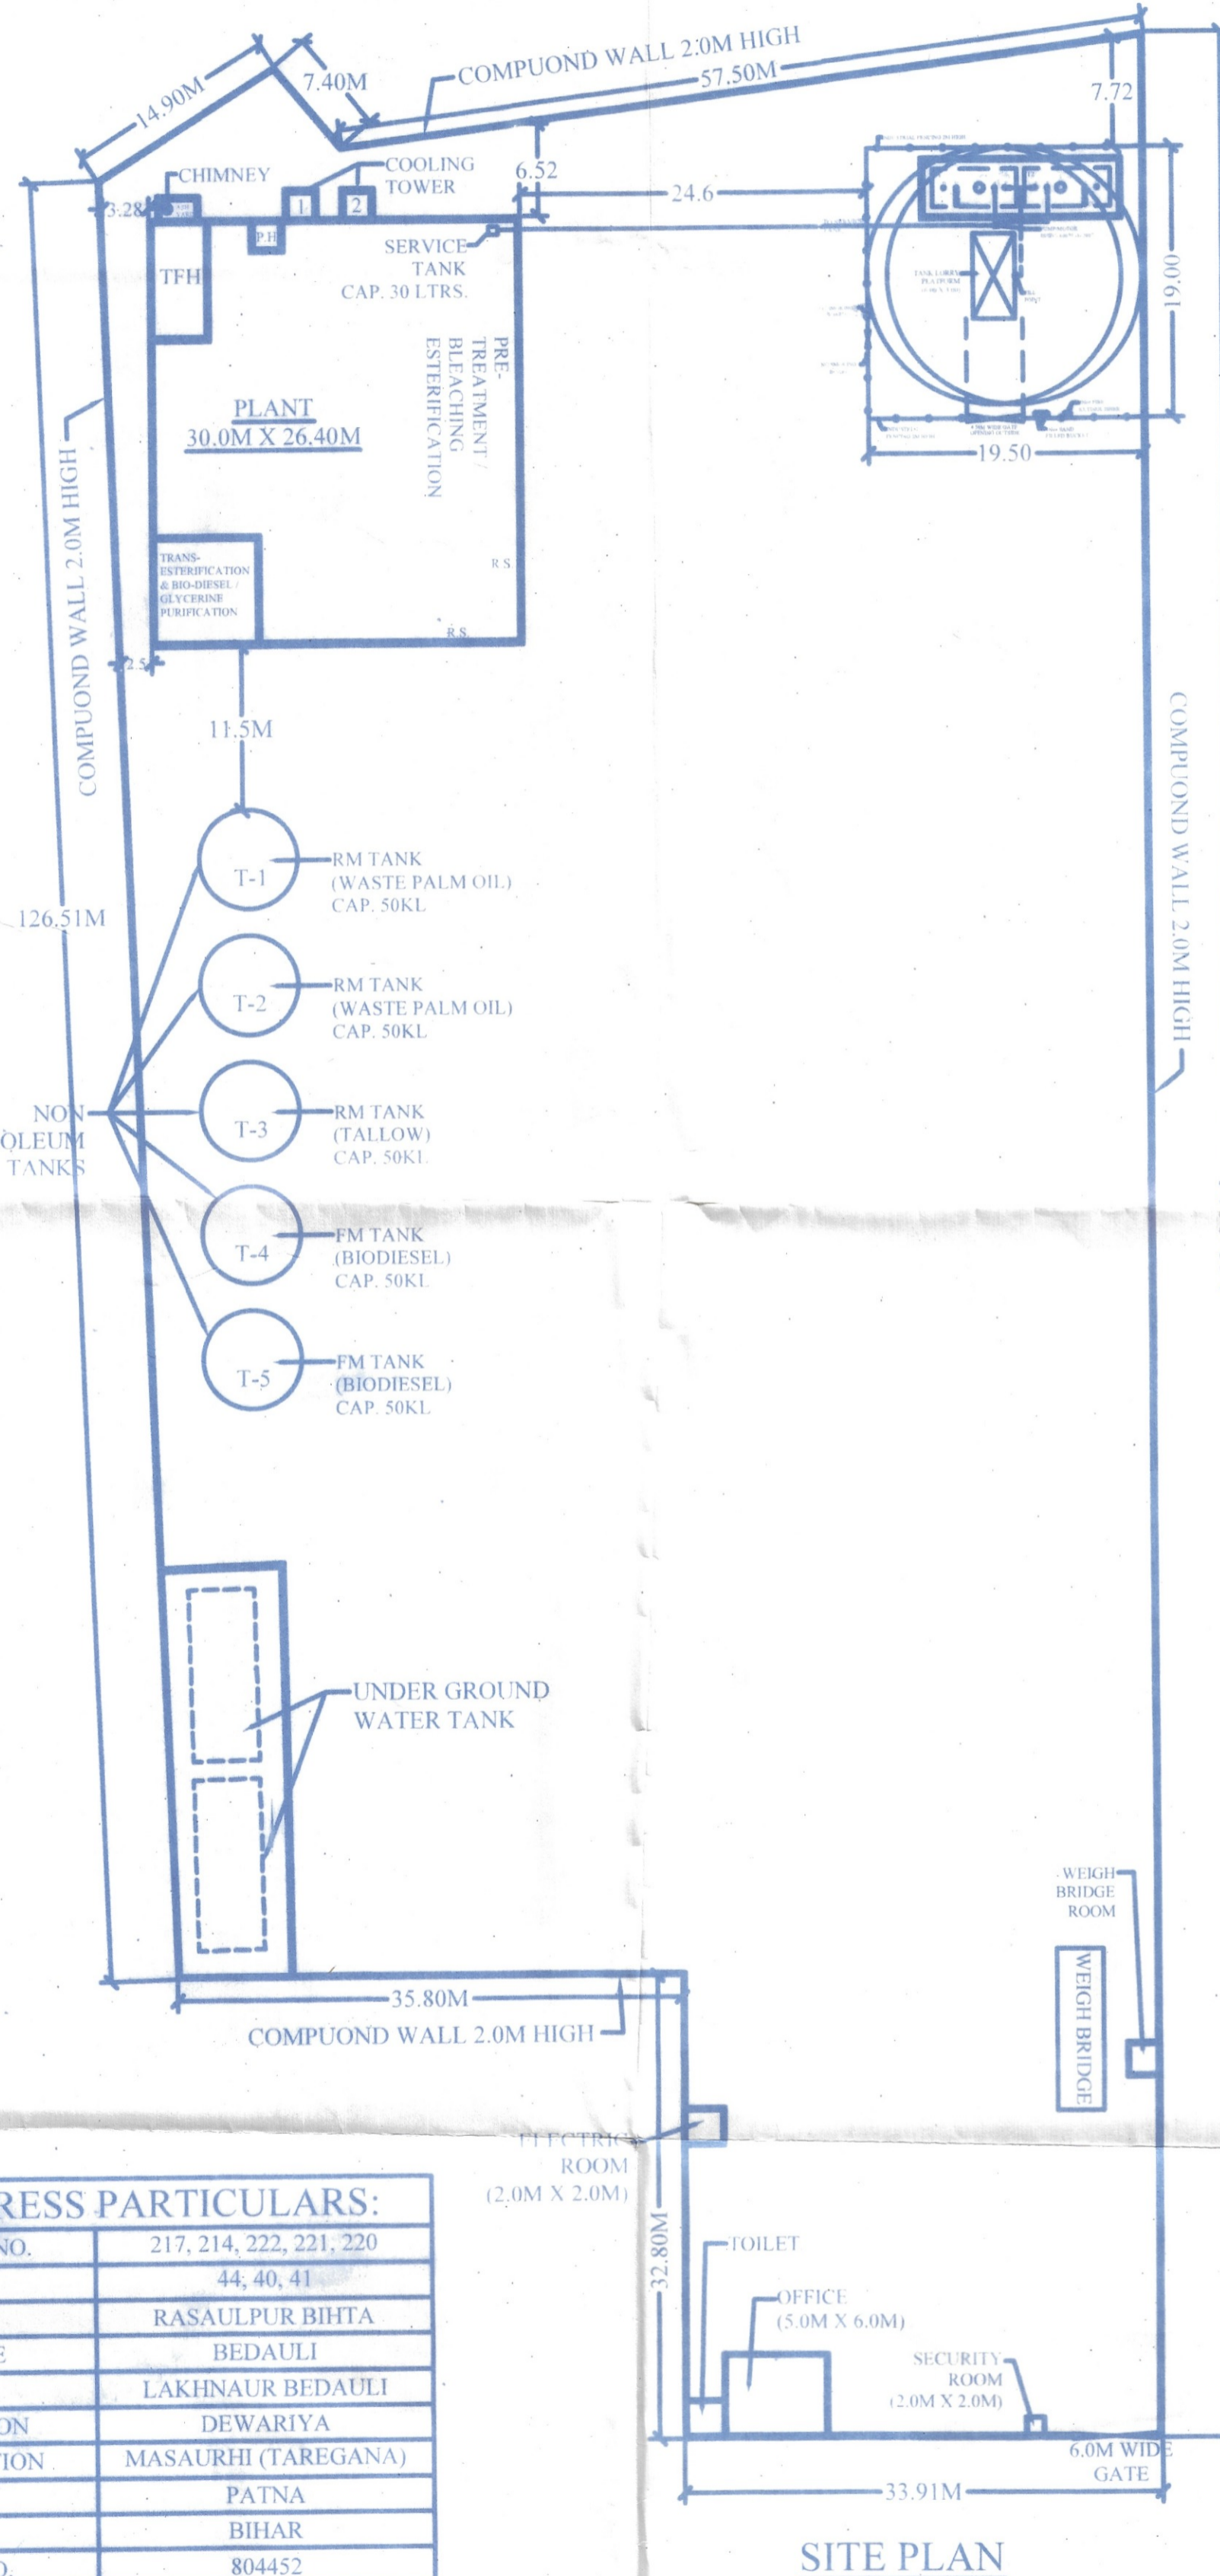

SITE PLAN

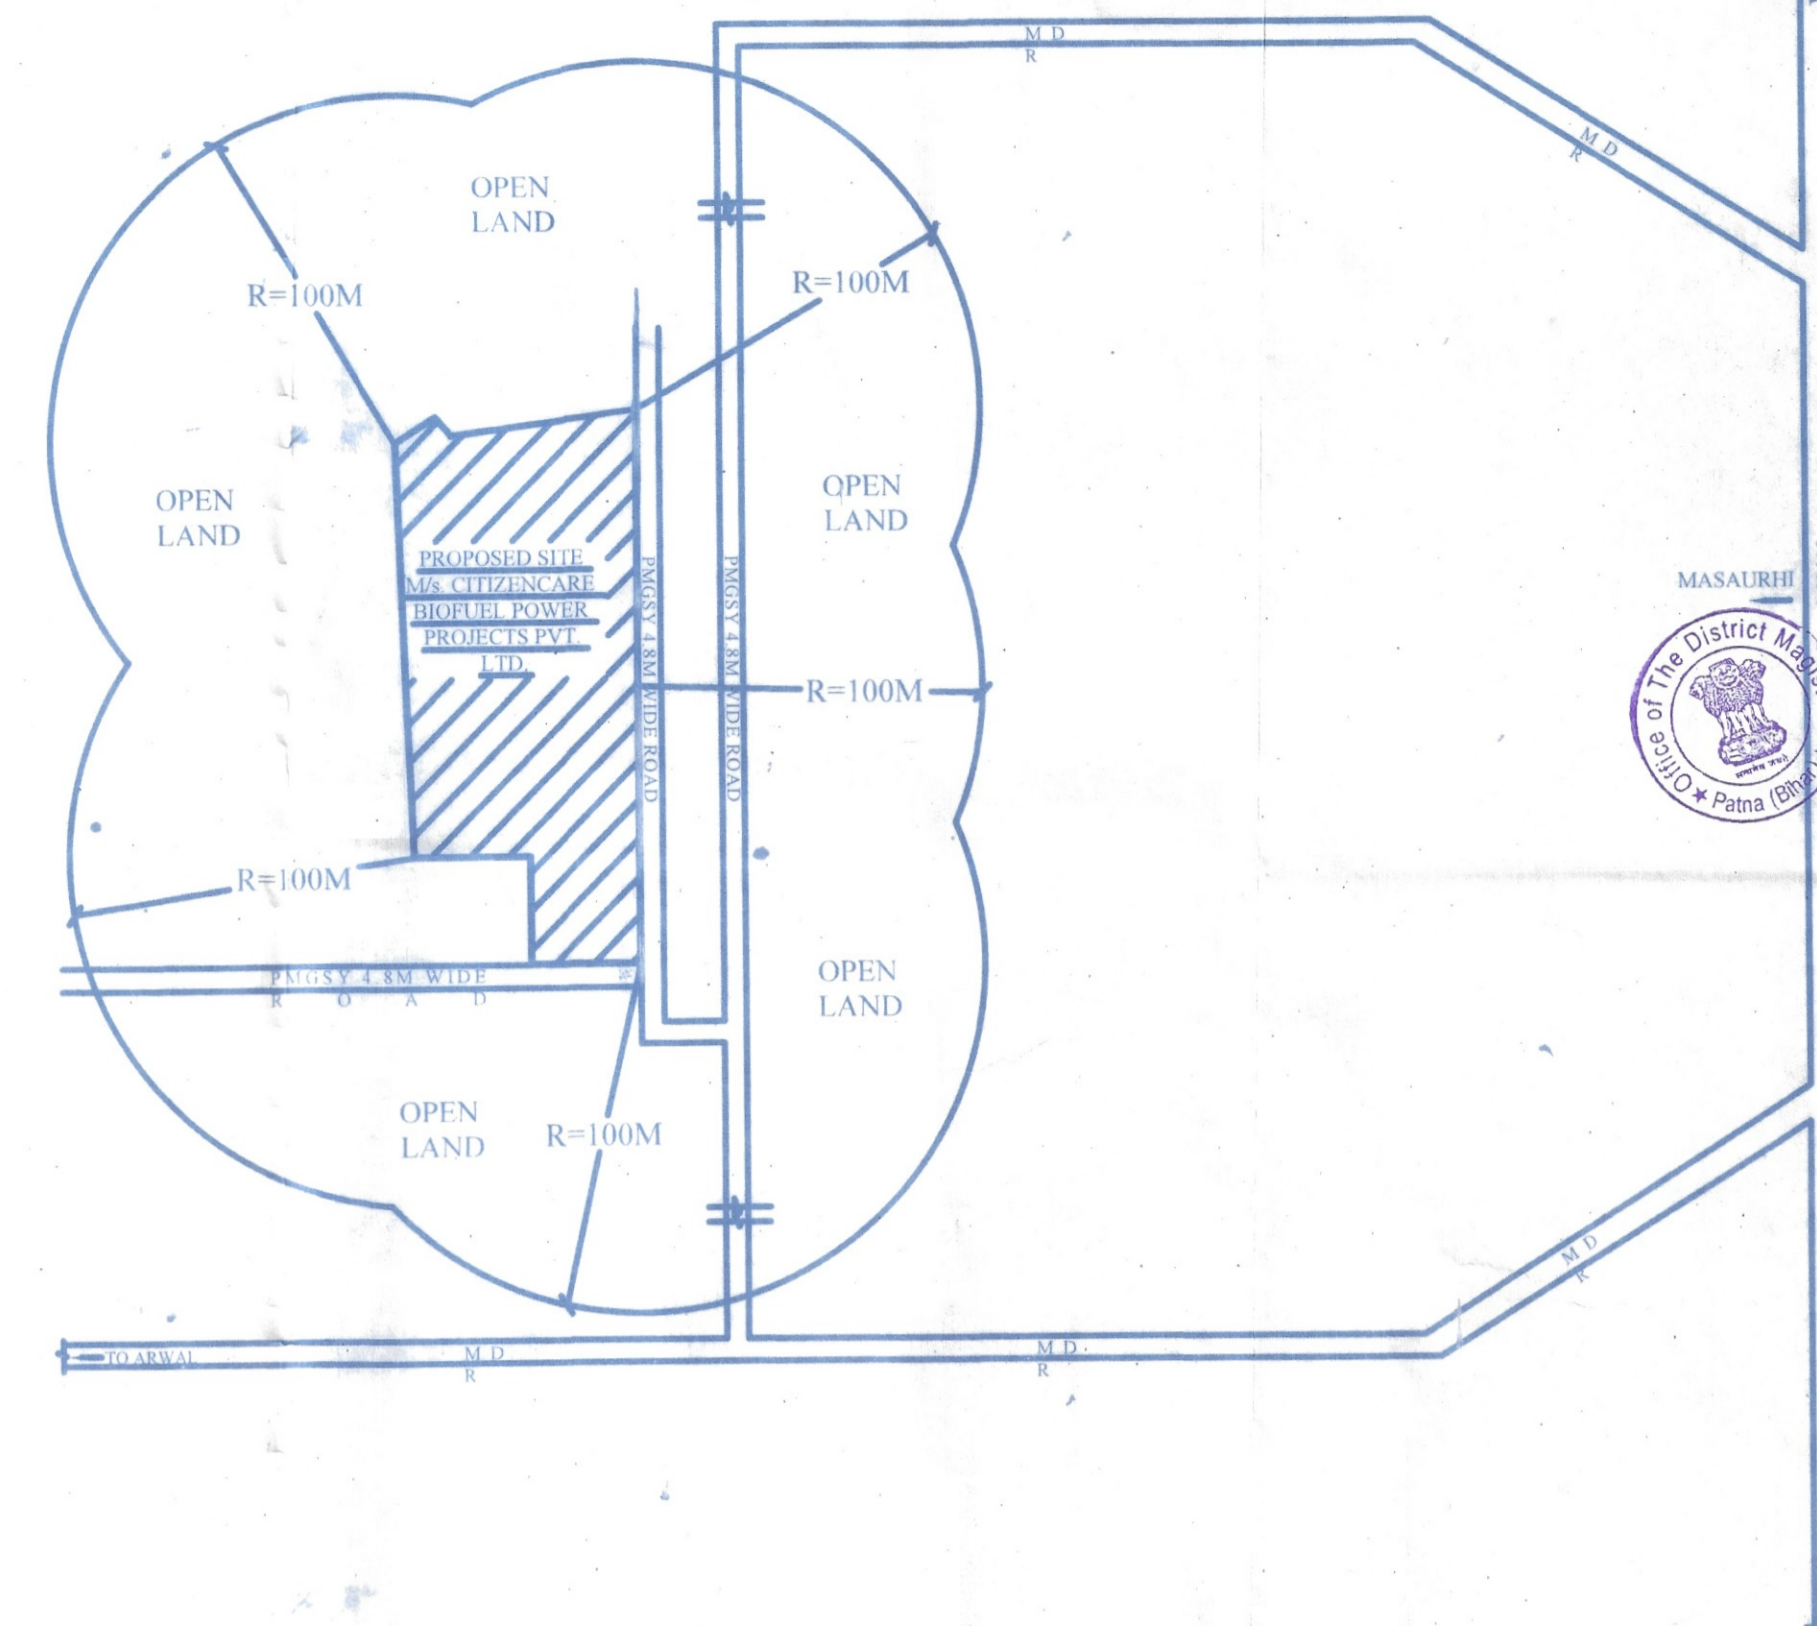

अपर जिला दंडाधिकारी
सामान्य शाखा, पटना।

TANK DETAILS :					
NO.	SIZE	CAPACITY	CLASS	PRODUCT	TYPE
T1	2.65M Ø X 6.00M LONG	30 KL.	'A'	METHANOL	U/G
T2	2.65M Ø X 6.00M LONG	30 KL.	'A'	METHANOL	U/G

NOZZLE DETAILS	
MARK	DESCRIPTION
S	SUCTION PIPE
D	DIP PIPE
V	VENT PIPE
M	MANHOLE
F	FILL PIPE
EVP	EXTENDED VENT PIPE

NOTES :

- TANKS SHALL BE PAINTED BY ANTI-CORROSIIVE PAINTS.
- TANKS SHALL BE PROPERLY EARTHED.
- ELECTRIC EQUIPMENTS AND FITTINGS SHALL CONFIRM TO IS:60079-1 STANDARDS
- U/G PIPE LINES PASS THROUGH SLEEVES & OVERHEAD PIPE LINES SHALL BE WELL SUPPORTED.
- INSTRUCTION BOARD'S :
" NO SMOKING PLEASE "
" EXPLOSIVES LICENCE NO...."
- EVP : EXTENDED VENT PIPE
- SFB : SAND FILLED BUCKETS OF CAP. 10KGS EACH
- FE : FIRE EXTINGUISHERS OF CAP. 9KGS EACH
- NSB: NO SMOKING BOARD DISPLAY
- TANKS WILL BE FABRICATE AS PER IS : 10987
- TFH THERMIC FLUID HEATER BIO-DIESEL.

PLAN SHOWING PROPOSED PETROLEUM CLASS 'A' IN TWO UNDER GROUND TANK OF CAPACITY 30KL EACH FOR OURBIO DIESEL PLANT UNDER PETROLEUM RULES 2002

M/s. CITIZENCARE BIOFUEL POWER PROJECTS PRIVATE LIMITED.

SURVEY PLOT NO. 217, 214, 222, 221, 220,
KHATA NO. 44, 40, 41,
MOUZA - RASAULPUR BIHTA,
TEHSIL - MASAUURHI (TAREGANA),
DISTT. - PATNA, (BIHAR) - 804452



Citizen Care Biofuel Power Projects Pvt. Ltd.

State Director APPLICANT

DRAWING NO. CBPPL/020/01 DATE. 19.08.2020

SITE ADDRESS PARTICULARS:	
SURVEY PLOT NO.	217, 214, 222, 221, 220
KHATA NO.	44, 40, 41
MOUZA	RASAULPUR BIHTA
POST OFFICE	BEDAULI
TEHSIL	LAKHNAUR BEDAULI
PLICE STATION	DEWARIYA
RAILWAY STATION	MASAUURHI (TAREGANA)
DISTRICT	PATNA
STATE	BIHAR
PIN CODE NO.	804452

LAYOUT PLAN FOR PETROLEUM CLASS 'A' (SCALE 1:100)